



Syracuse Haulers
Proposed Transfer Station

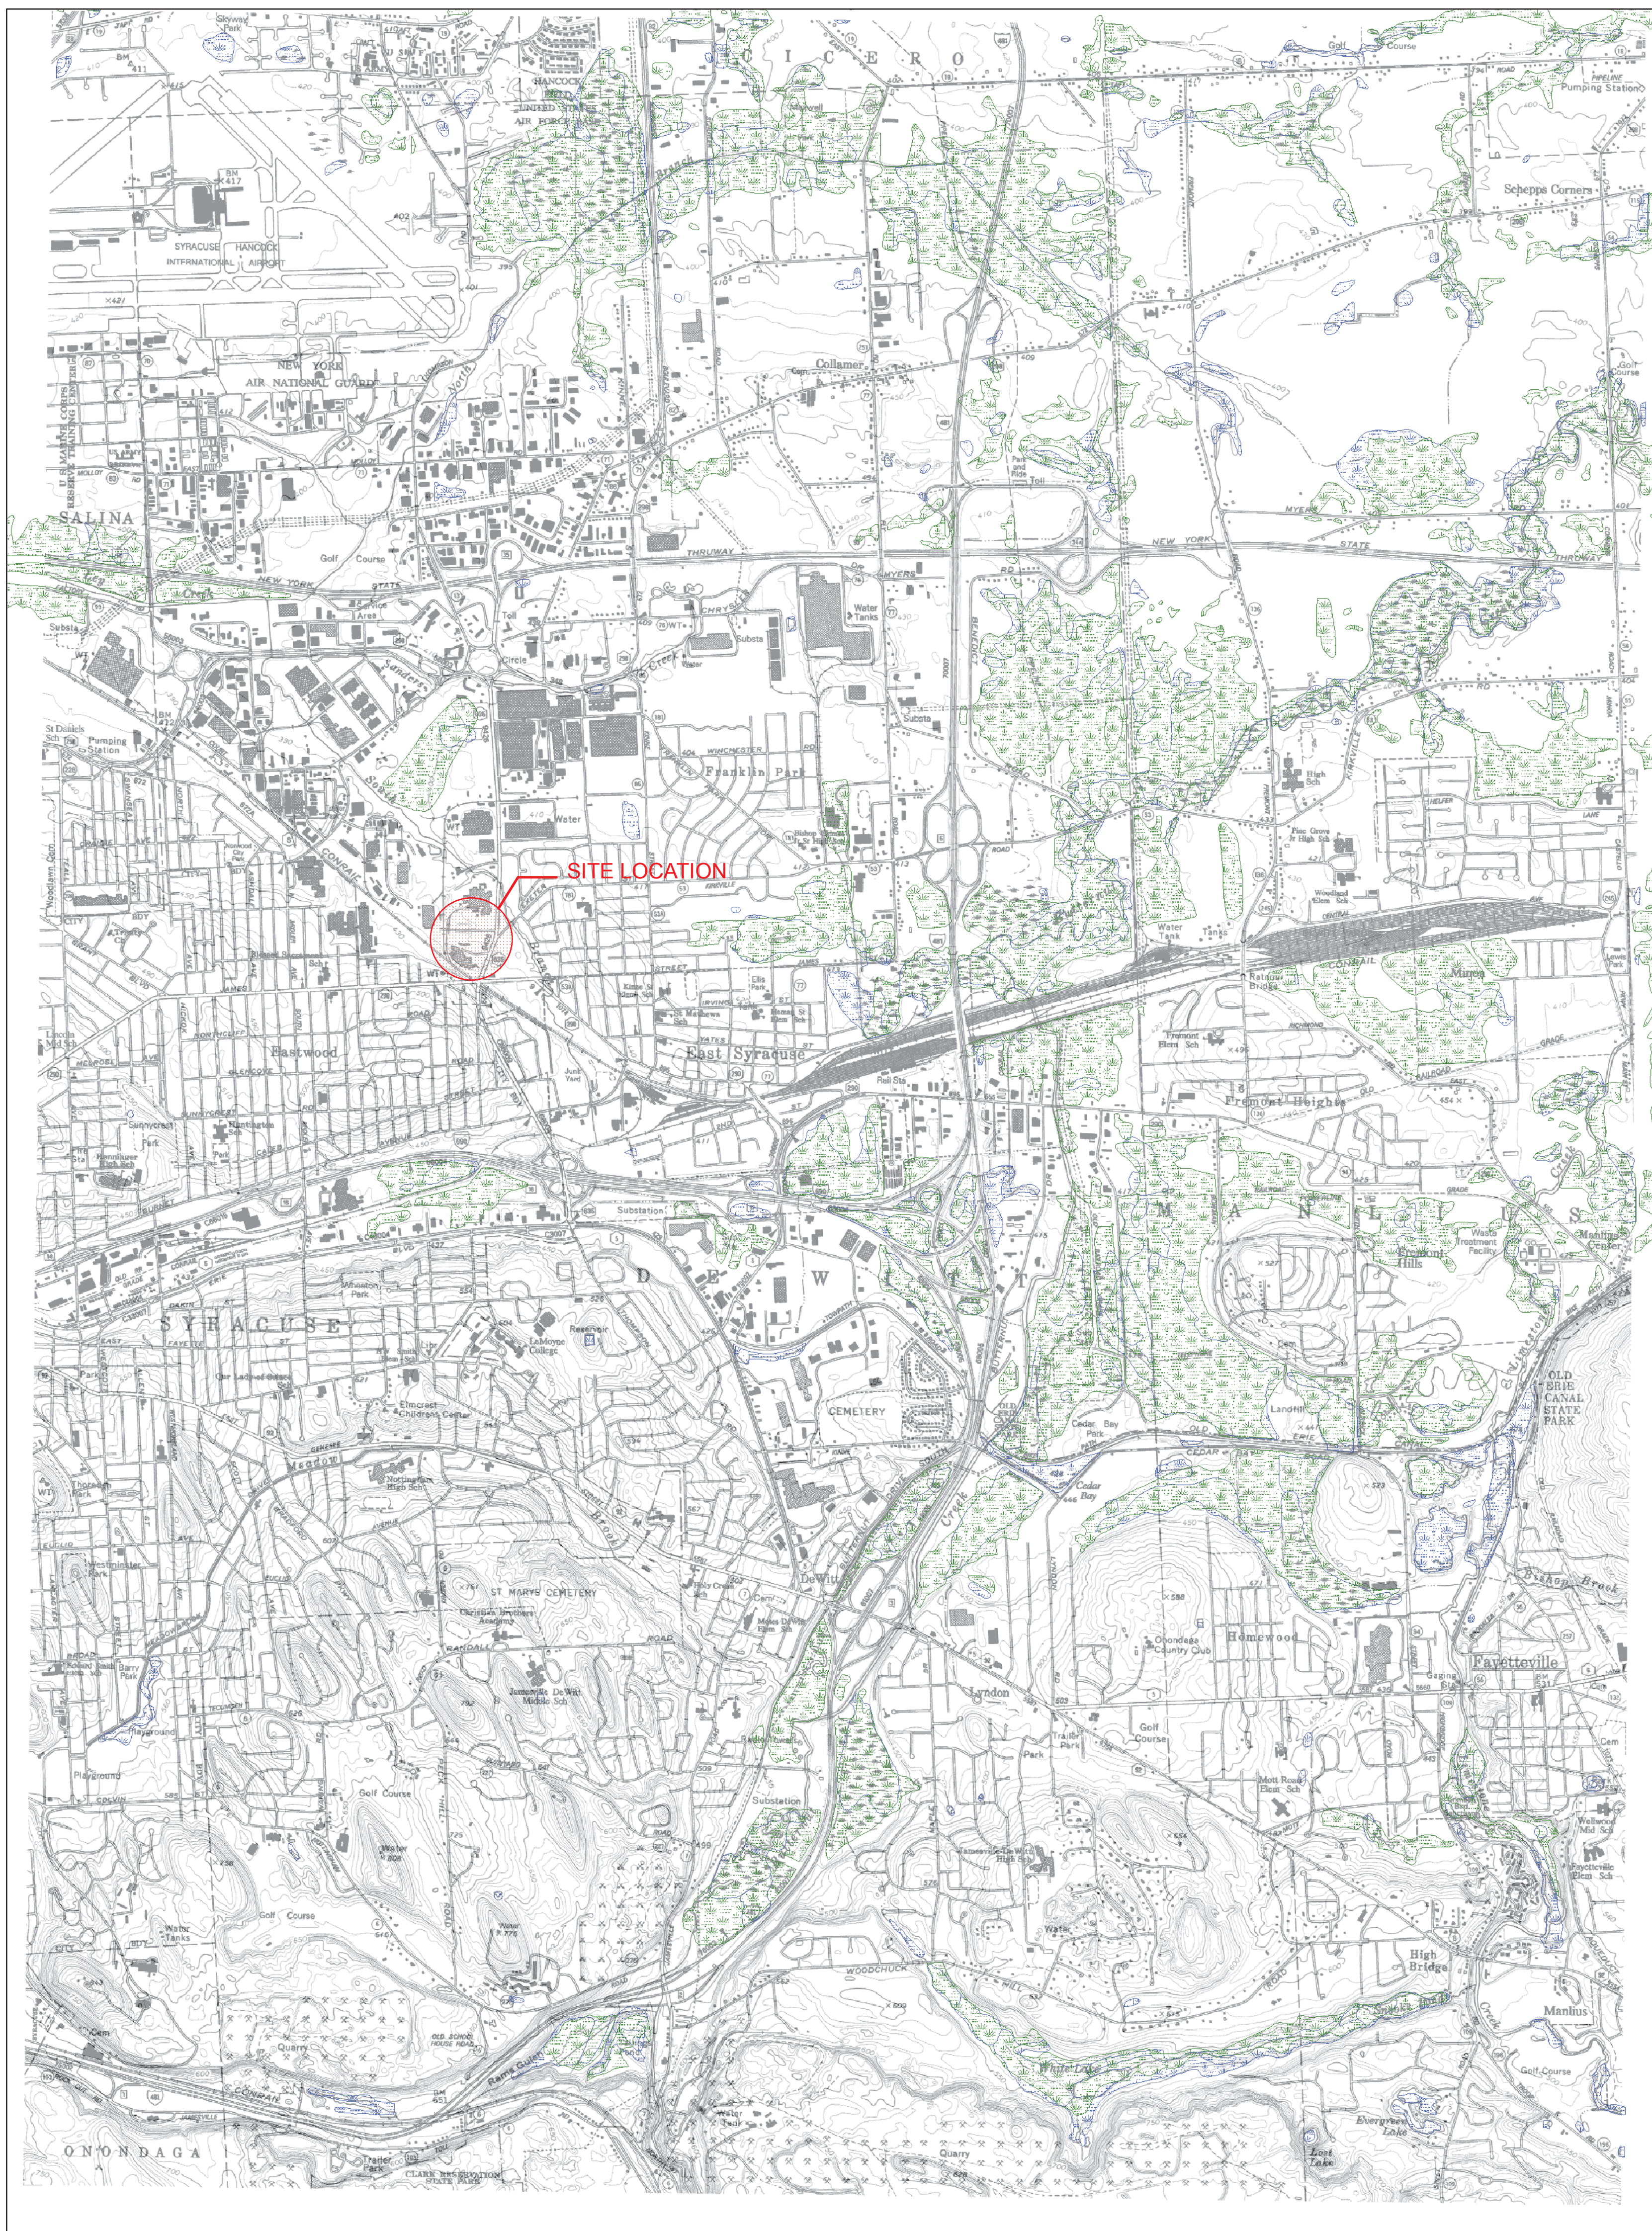


Legend

- DEC Wetlands
- Federal Wetlands

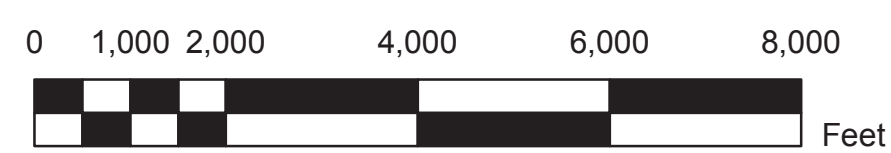


W-M ENGINEERING, DPC
P.O. Box 37, Syracuse, New York 13209
(315) 952-8159 wnorse@wmengineers.com

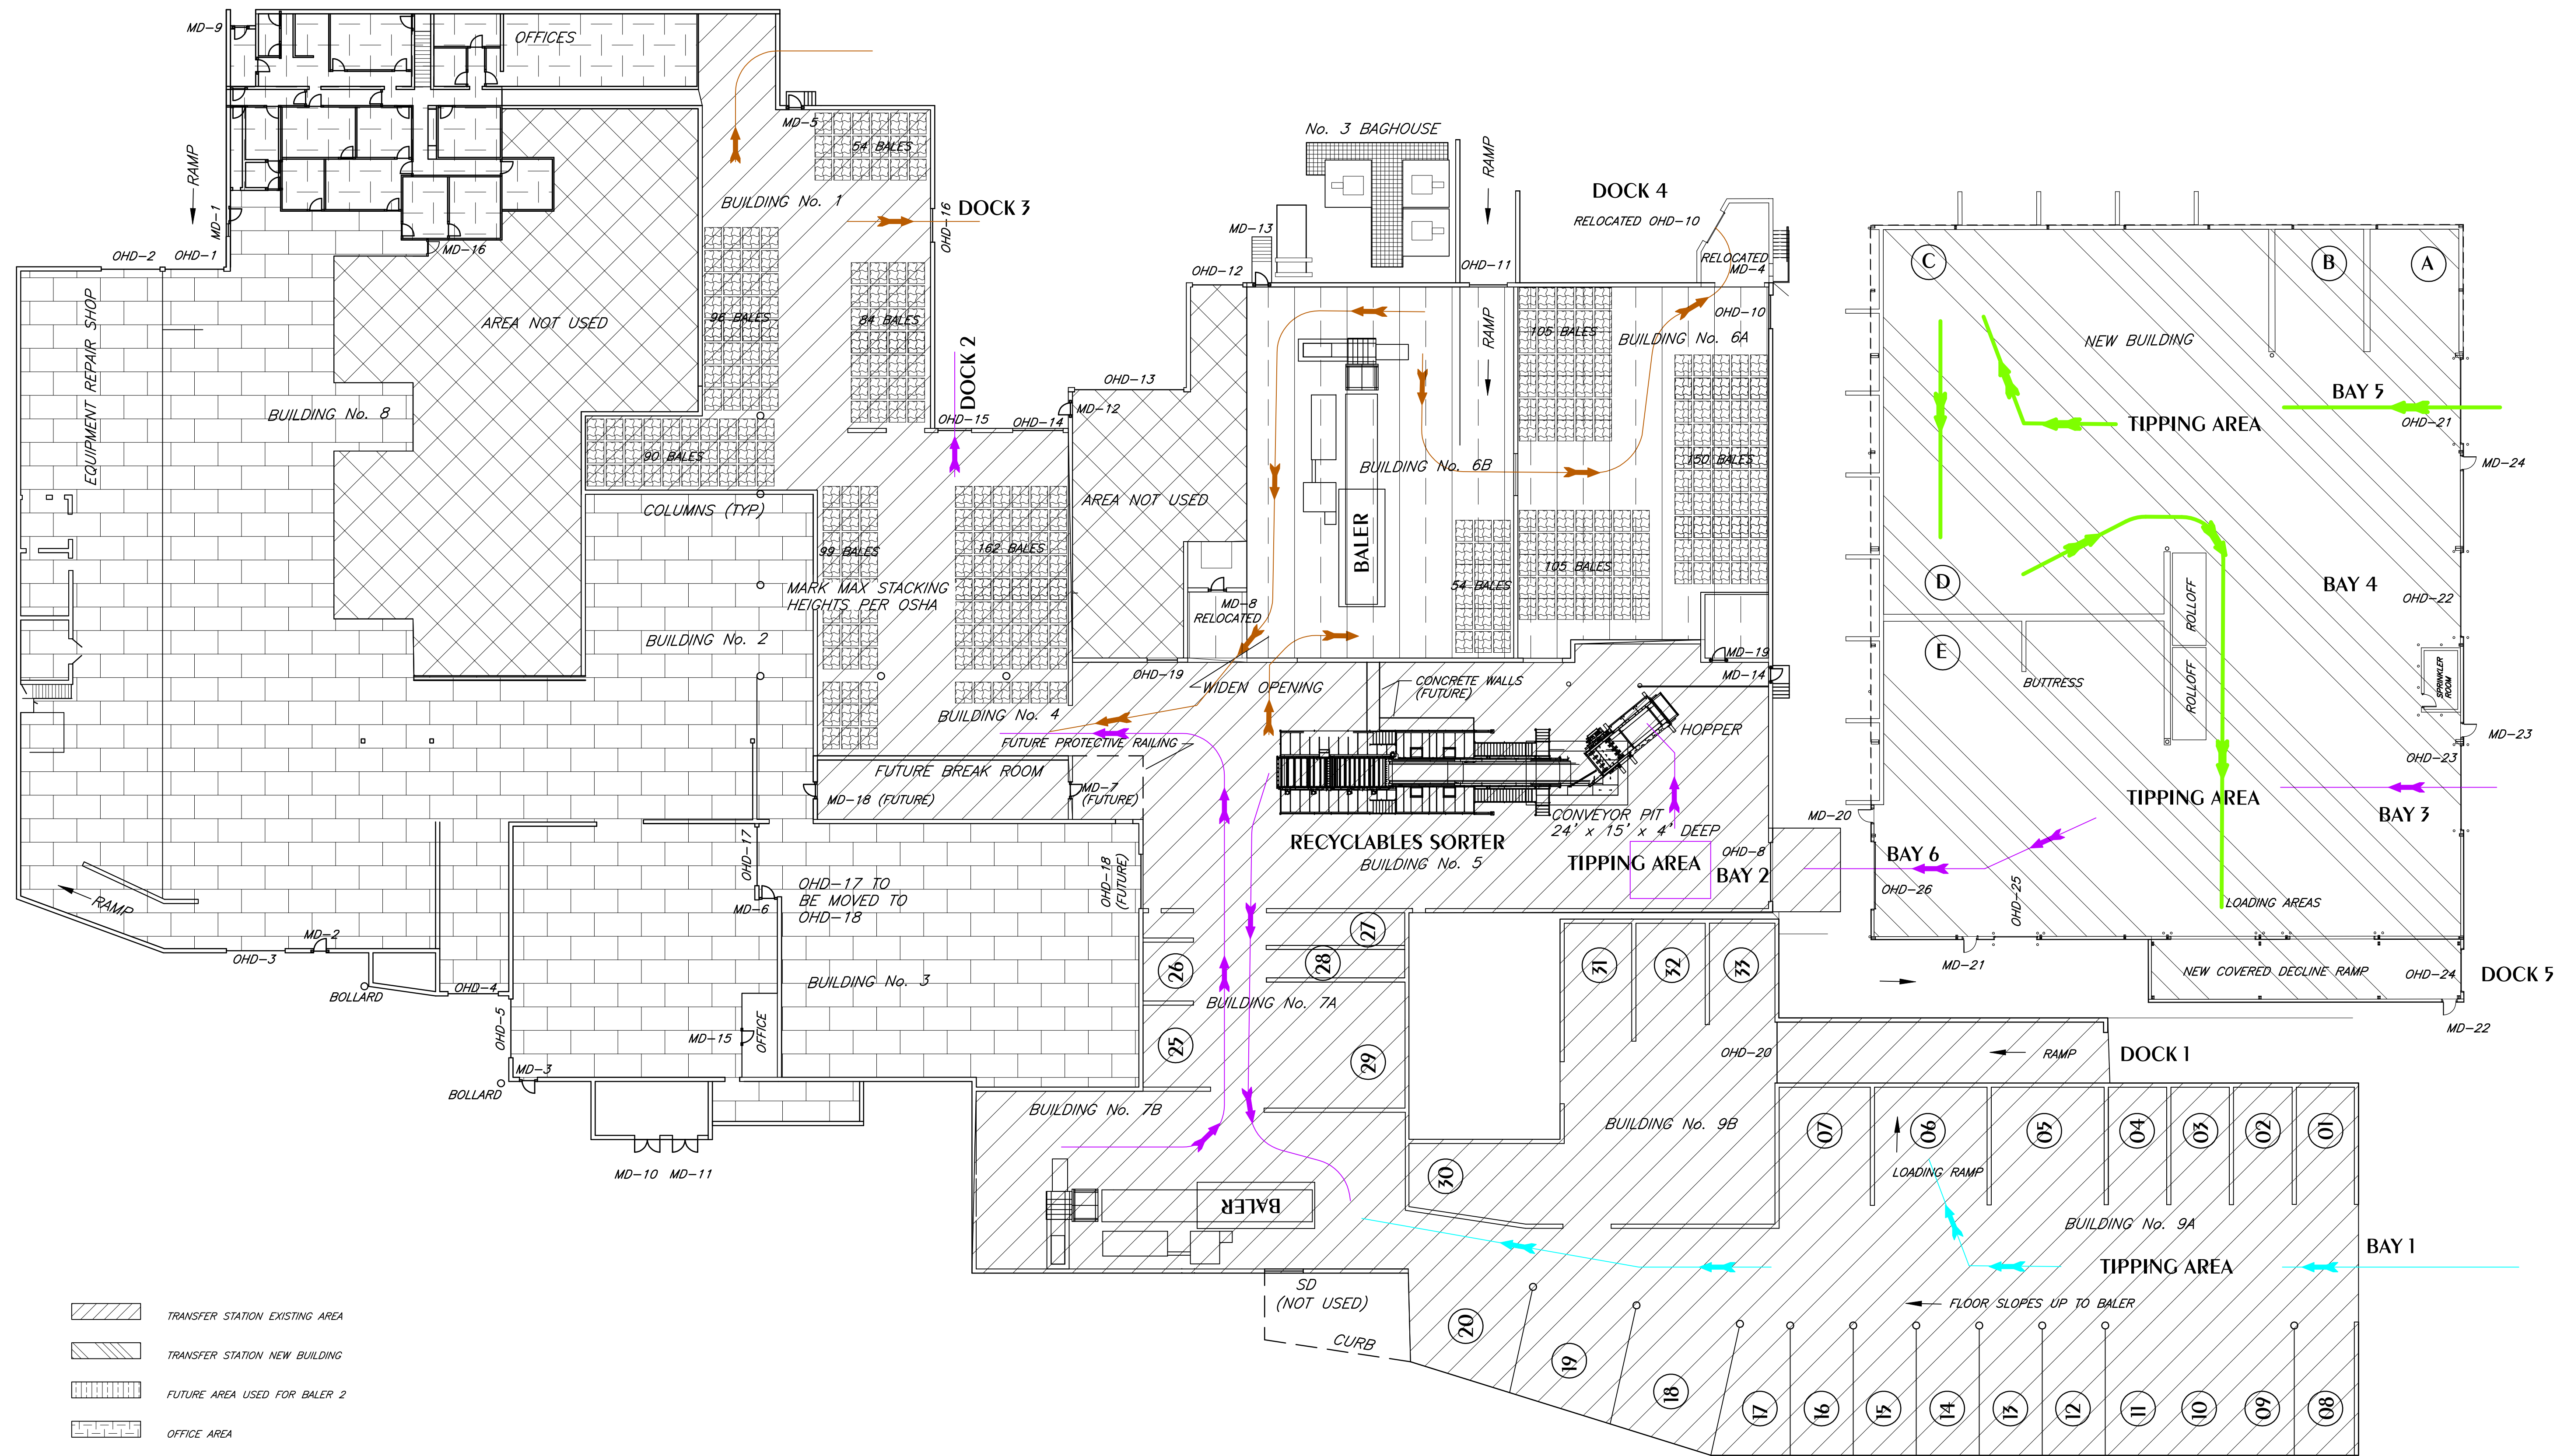


- TRANSFER STATION EXISTING AREA
- TRANSFER STATION NEW BUILDING
- FUTURE AREA USED FOR BALER 2
- OFFICE AREA
- EQUIPMENT REPAIR AND PARTS STORAGE
- UNUSED AREAS
- EXISTING BIN NUMBERS
- NEW BIN LETTERS
- BAY 1 MATERIAL FLOW
- BALER 1 MATERIAL FLOW
- BALER 2 MATERIAL FLOW
- BAY 5 MATERIAL FLOW

PLAN
SCALE 1" = 20'


WASTEWATER DRAINAGE 	W-M ENGINEERING, DPC 101 PIERCEFIELD DR, SOLVAY, NY 13209 315-952-8159 wnmorse@wmengineers.com	HIGHWAY WATER
EXHIBIT B FLOOR PLAN EXISTING AND NEW BUILDINGS		
SYRACUSE HAULERS FACILITY EXPANSION		
TOWN OF DEWITT	COUNTY OF ONONDAGA	
NO ALTERATION PERMITTED HEREON EXCEPT AS PROVIDED UNDER SECTION 7209 SUBDIVISION 2 OF THE NEW YORK EDUCATION LAW. DATE: JULY 20, 2021	SCALE: AS NOTED DRAWN BY: WDM CHECKED BY:	REVISED: 9/13/24 JOB NO. 202104 DWG NO. 202104-1FP SHEET NO. OF

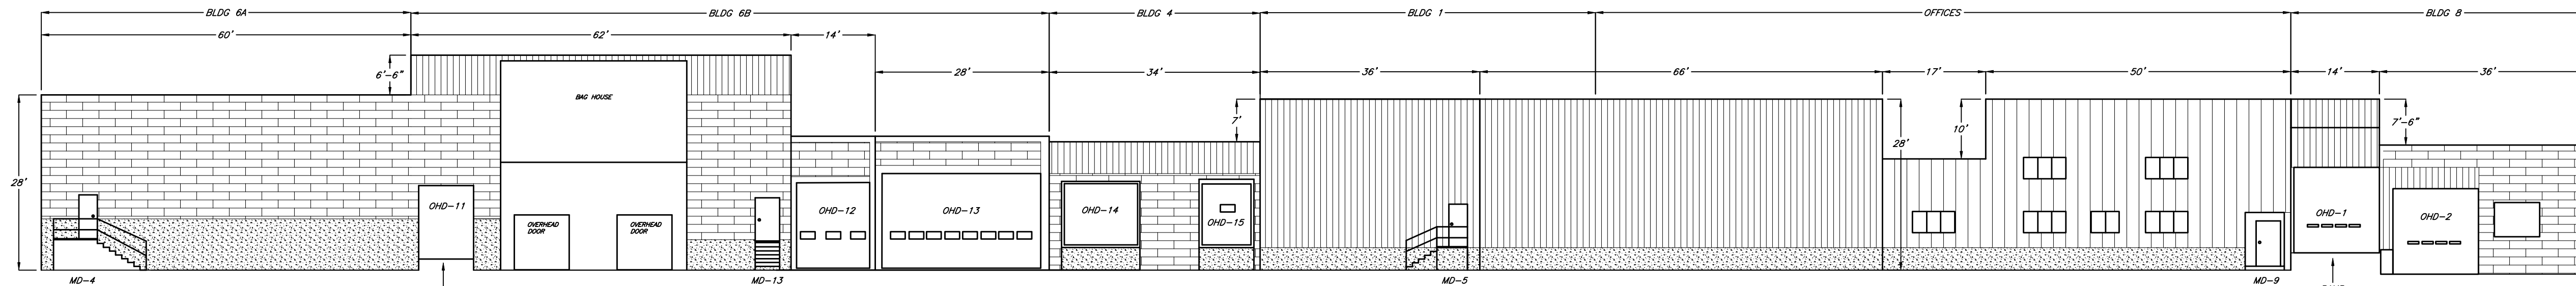


NORTH ELEVATION - BUILDING 6A, 6B, 4, 1, OFFICES AND 8
SCALE: 1/16"=1'-0"

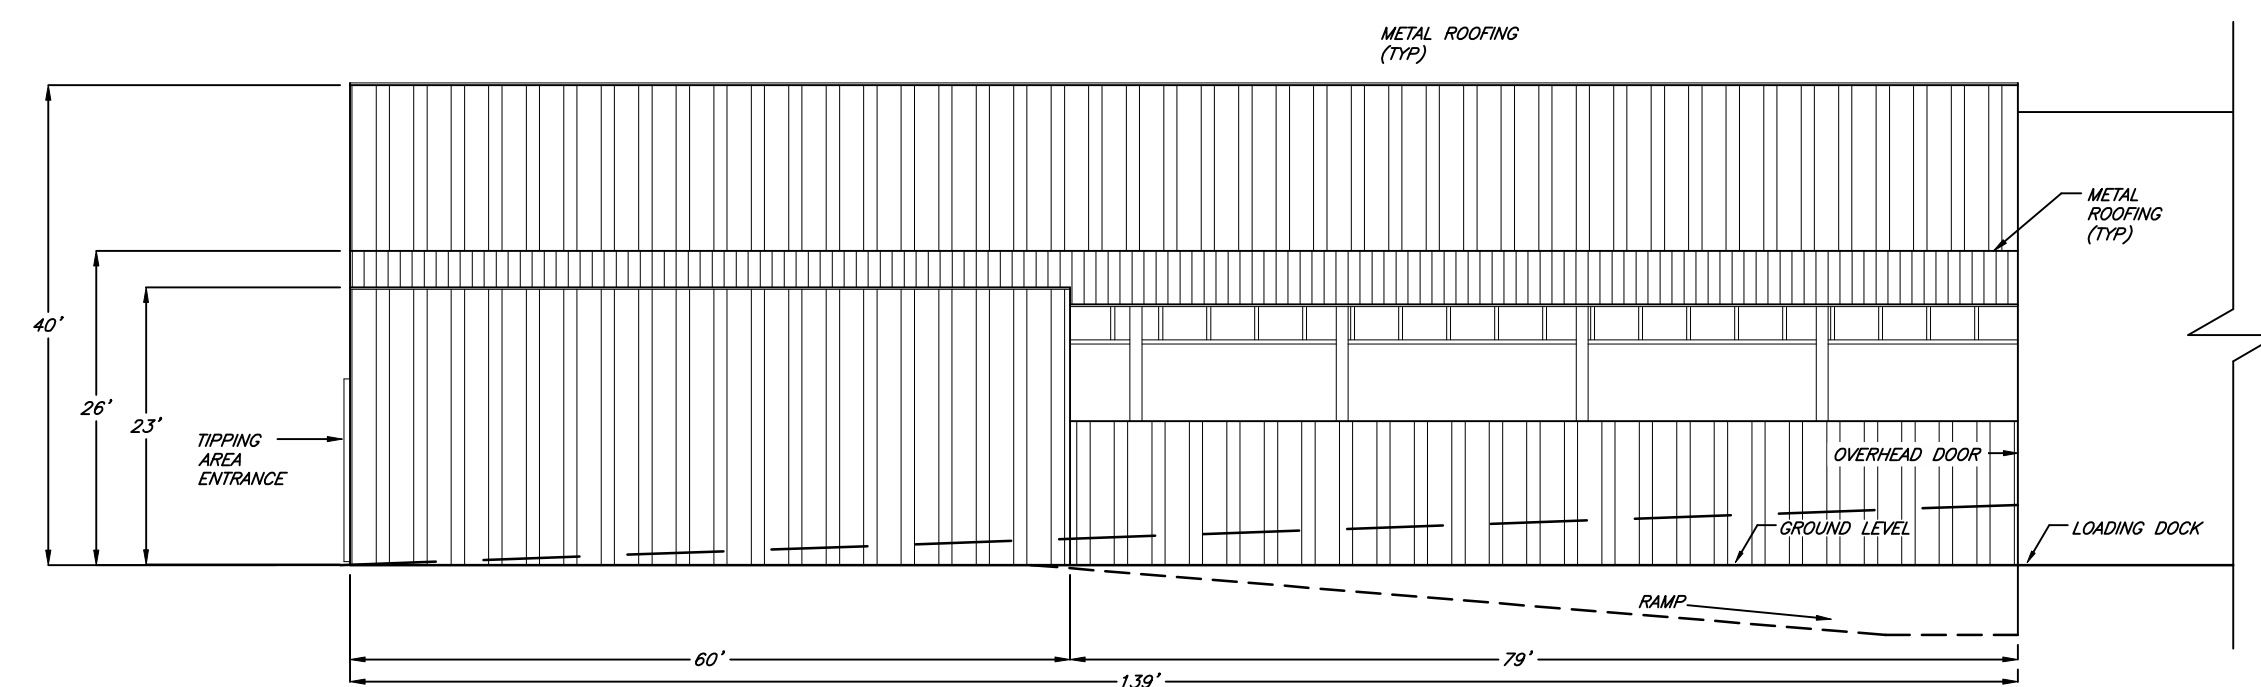

NORTH ELEVATION - BUILDING 9A
SCALE: 1/16"=1'-0"

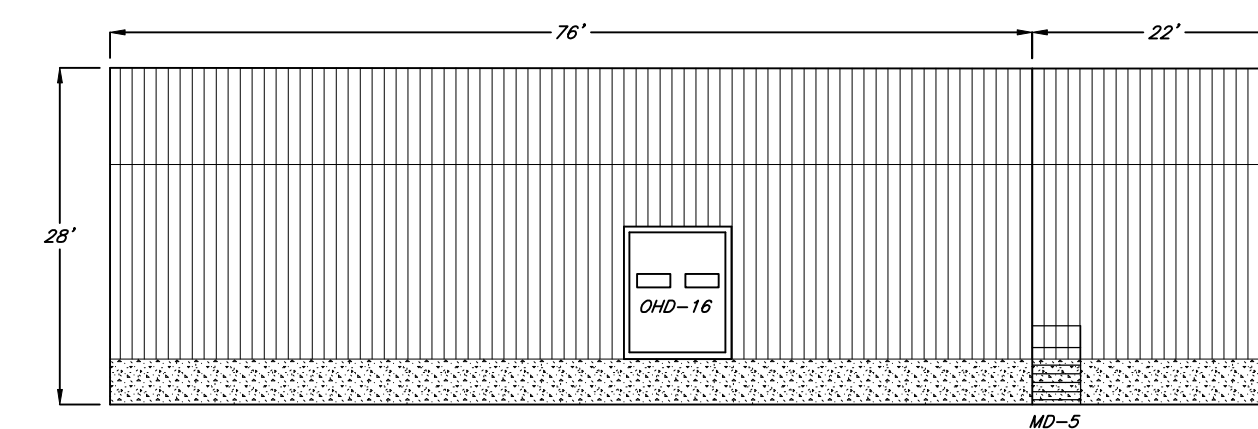

EAST ELEVATION - BUILDING 1
SCALE: 1/16"=1'-0"

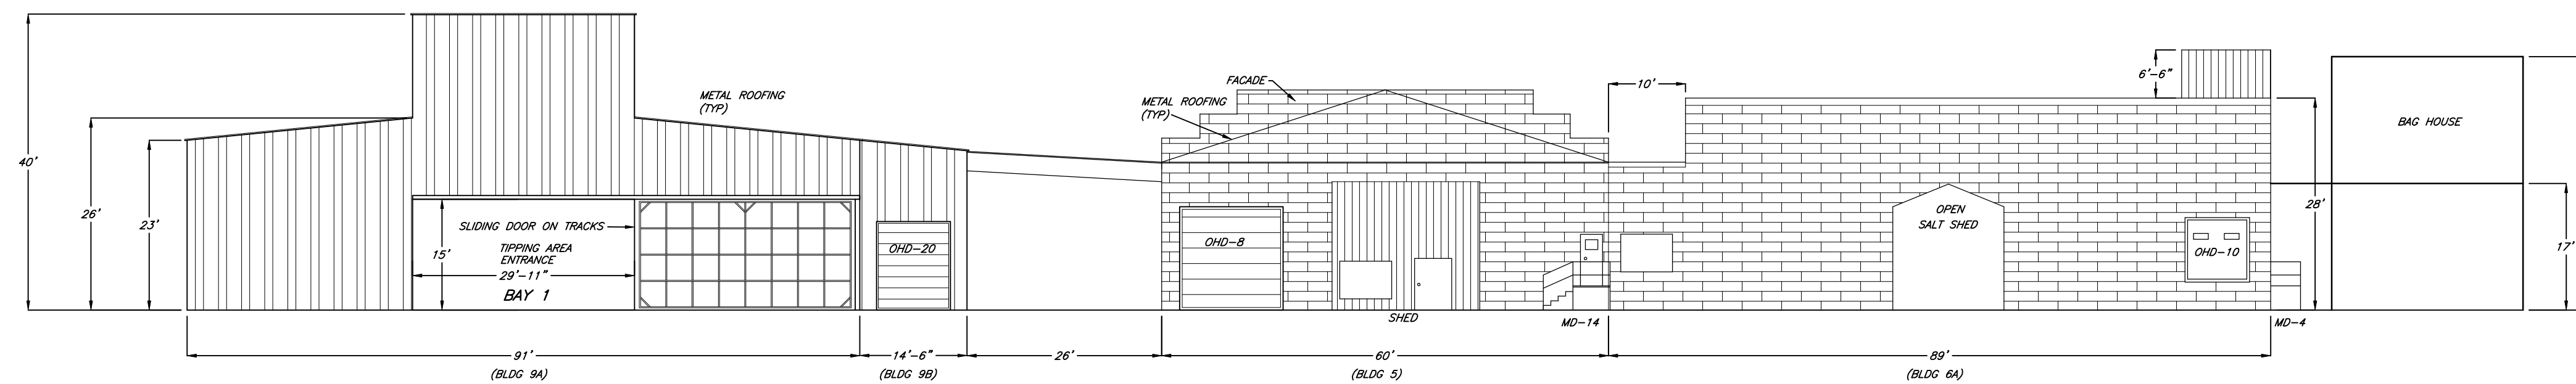

EAST ELEVATION - BUILDING 9A, 9B, 5, AND 6A
SCALE: 1/16"=1'-0"

Overhead Doors

Door No.	Width Feet	Height Feet	Material	Windows	Above Grade	Ramp	Comments
OHD-1	14	14	Metal	Yes	No	Yes	Ramp
OHD-2	14	14	Metal	Yes	No	No	
OHD-8	14	14	Metal	No	No	No	Ramp
OHD-10	8	8	Metal	Yes	Yes 4'	No	Dock 5
OHD-11	9	12	Wood	No	Yes 2'	Yes	Ramp
OHD-12	12	14	Metal	Yes	No	No	
OHD-13	26	15.5	Metal	Yes	No	No	
OHD-14	12	9.5	Metal	No	Yes 4' 2"	No	Not used
OHD-15	8	10	Metal	Yes	Yes 4' 2"	No	Dock 2
OHD-16	8	10	Metal	Yes	Yes 4' 7"	Yes	Dock 3
OHD-20	10	12	Metal	No	No	Yes	Dock 1

Man Doors

Door No.	Width Feet	Height Feet	Material	Windows	Above Grade	Stairs	Comments
MD-4	3	7	Metal	No	Yes 5' 8"	Yes	7 steps
MD-5	3	7	Metal	No	Yes 3' 8"	Yes	4 steps
MD-9	4	7	Glass	Yes	No	Yes	1 step; Office entrance; recessed
MD-13	3	7	Metal	No	Yes 4' 6"	Yes	7 steps
MD-14	3	7	Metal	Yes	Yes 2' 6"	Yes	4 steps

WASTEWATER
DRAINAGE



W-M ENGINEERING, DPC
101 PIERCEFIELD DR, SOLVAY, NY 13209
315-952-8159 wmo@wmengineers.com

HIGHWAY
WATER

EXHIBIT C1
NORTH AND EAST ELEVATIONS
EXISTING BUILDINGS

SYRACUSE HAULERS
FACILITY EXPANSION


COUNTY OF
ONONDAGA

NO ALTERATION PERMITTED HEREON EXCEPT AS PROVIDED UNDER SECTION 2209 SUBDIVISION 2 OF THE NEW YORK EDUCATION LAW.
DATE: AUGUST 26, 2022


SCALE: AS NOTED
DRAWN BY: WDM
CHECKED BY:

REVISED: 9/13/24

JOB NO. C104
DWG NO. C104-BE
SHEET NO. OF

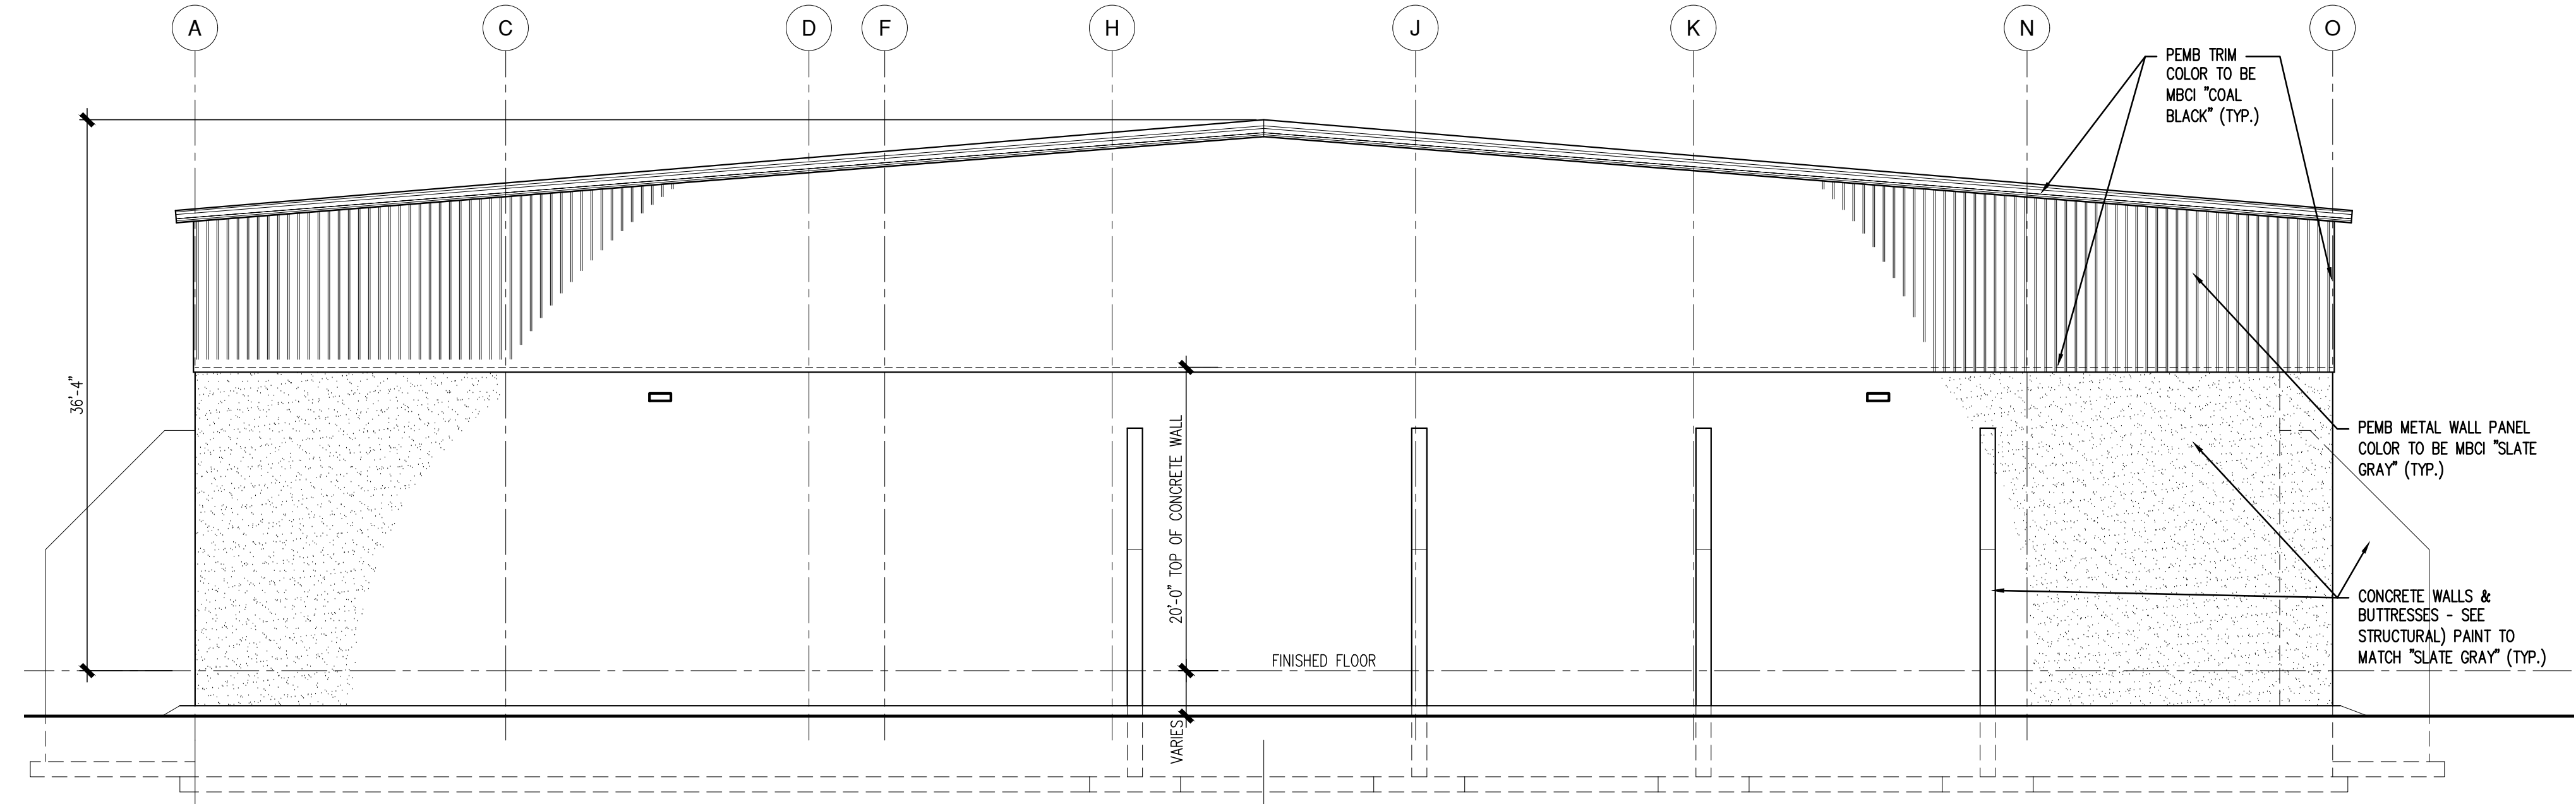

1 NORTH ELEVATION
SCALE 1/8" = 1'-0"

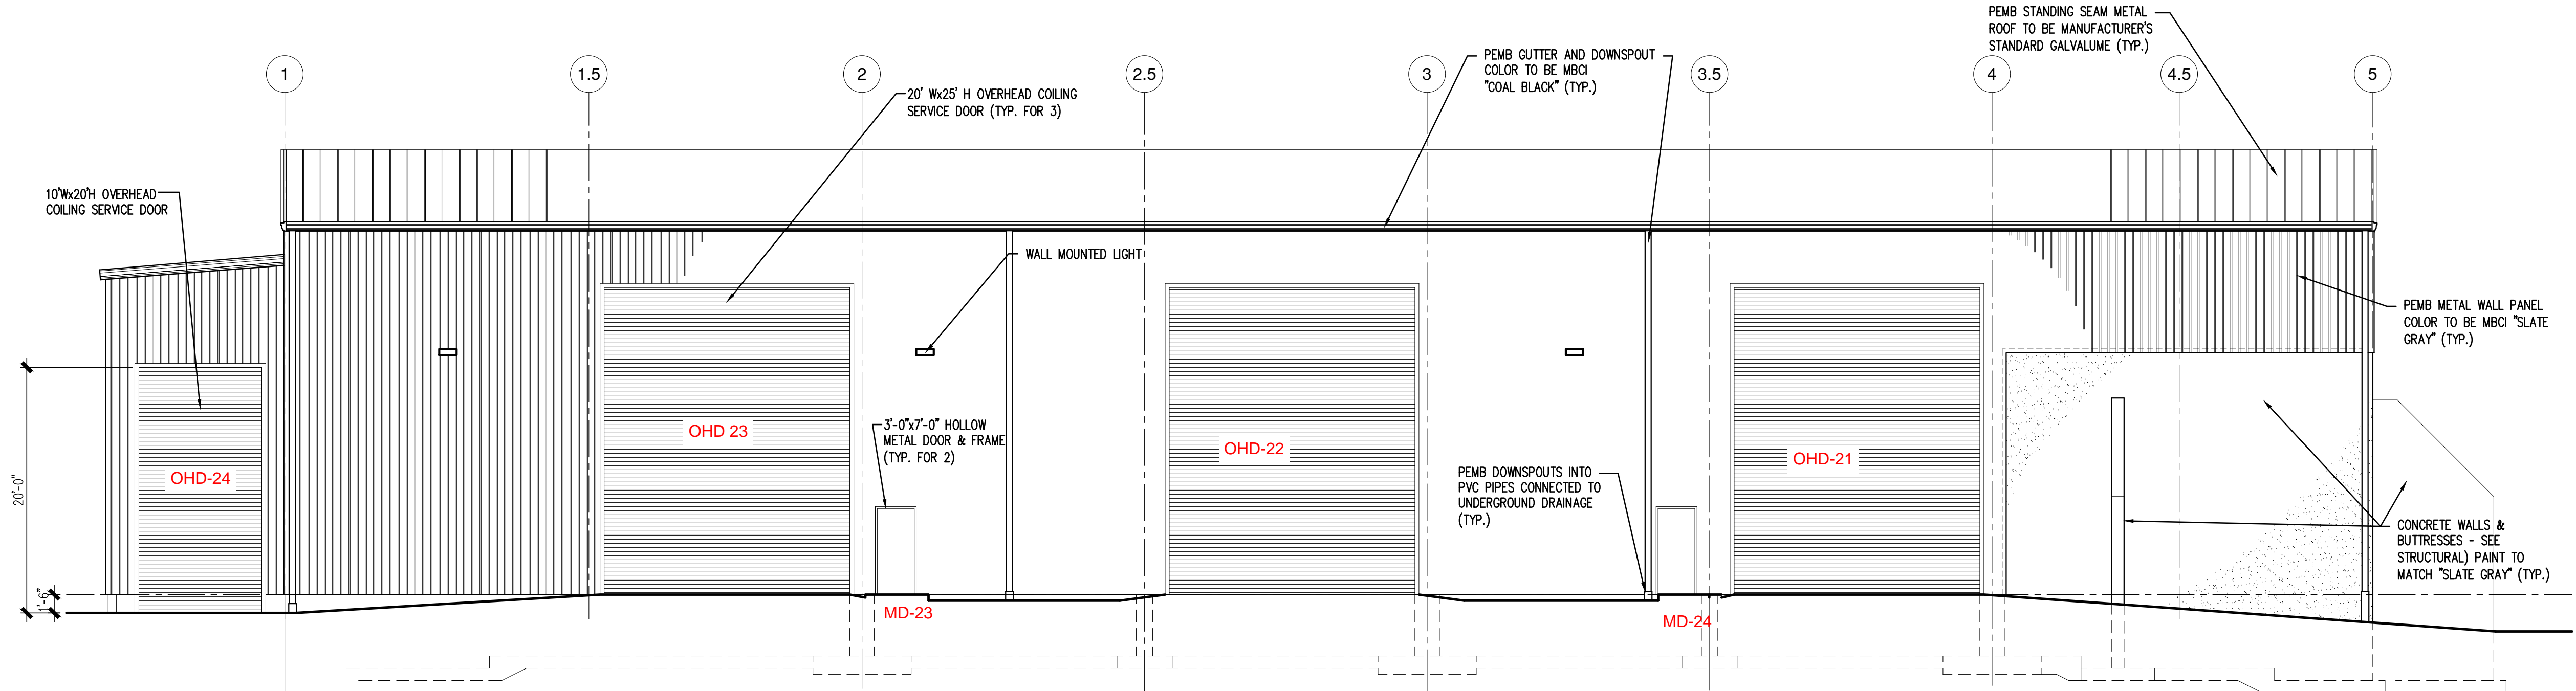

2 EAST ELEVATION
SCALE 1/8" = 1'-0"

VOLTAIRE ARCHITECTURAL WALL PACK

WVP LED

PROJECT: _____ DATE: _____

CROSS SECTIONS

WVP Range 2132a

ORDERING INFORMATION

FINISH OPTIONS

SHIELDING

OPTIONS

ACCESSORIES

WVP LED FEATURES

GENERAL

CONDUCTIVITY

CONDUIT ENTRY

DISTRIBUTION

WVP ONLY

FINISH OPTIONS

SHIELDING

OPTIONS

ACCESSORIES

H.E. Williams, Inc. • Carthage, Missouri • www.hew.com • 417-358-4055

VOLTAIRE ARCHITECTURAL WALL PACK

WVP LED

LED SPECIFICATIONS

DISTRIBUTION

FIXTURE PERFORMANCE DATA

SERIES	DISTRIBUTION	LUMENS PACKAGE	WATTAGE	CCT	CLEAR CLASS (CU)		BUILT-IN CLASS (DU)		BIP	RATINGS
					FOOT/FOOT	FOOT/FOOT	FOOT/FOOT	FOOT/FOOT		
WVP	T3	L30	36	3000	3170	88.2	2983	82.3		81-101-01
		L30	70	5000	2410	95.5	2290	89.1		81-101-01
	T3T	L30	36	4000	6810	12.1	6370	81.1		81-101-01
		L30	70	5000	2760	75.4	2520	82.4		81-101-01
WVP	T3	L30	36	4000	2814	79.1	2803	72.4		81-101-01
		L30	70	4800	1918	62.9	1680	72.4		81-101-01
	T3T	L30	36	4800	5470	16.1	5063	72.4		81-101-01
		L30	70	5800	3676	82.9	3480	78.4		81-101-01

BOLT PATTERN DETAIL

H.E. Williams, Inc. • Carthage, Missouri • www.hew.com • 417-358-4055

VOLTAIRE ARCHITECTURAL WALL PACK

WVP LED

OPTIONS

OCCURS FSP-211 - L2

OCCUPANCY SENSOR

LED SPECIFICATIONS


SHIELDING

OPTIONS


ACCESSORIES

H.E. Williams, Inc. • Carthage, Missouri • www.hew.com • 417-358-4055

THE ARCHITECT SHALL BE DEEMED TO HAVE ACCEPTED THE GENERAL CONDITIONS OF CONTRACT AND SHALL BE RESPONSIBLE FOR THE STATUTORY AND OTHER RESERVED RIGHTS, INCLUDING THE COPYRIGHT, DRAWING ALTERATION, AND REVISIONS.

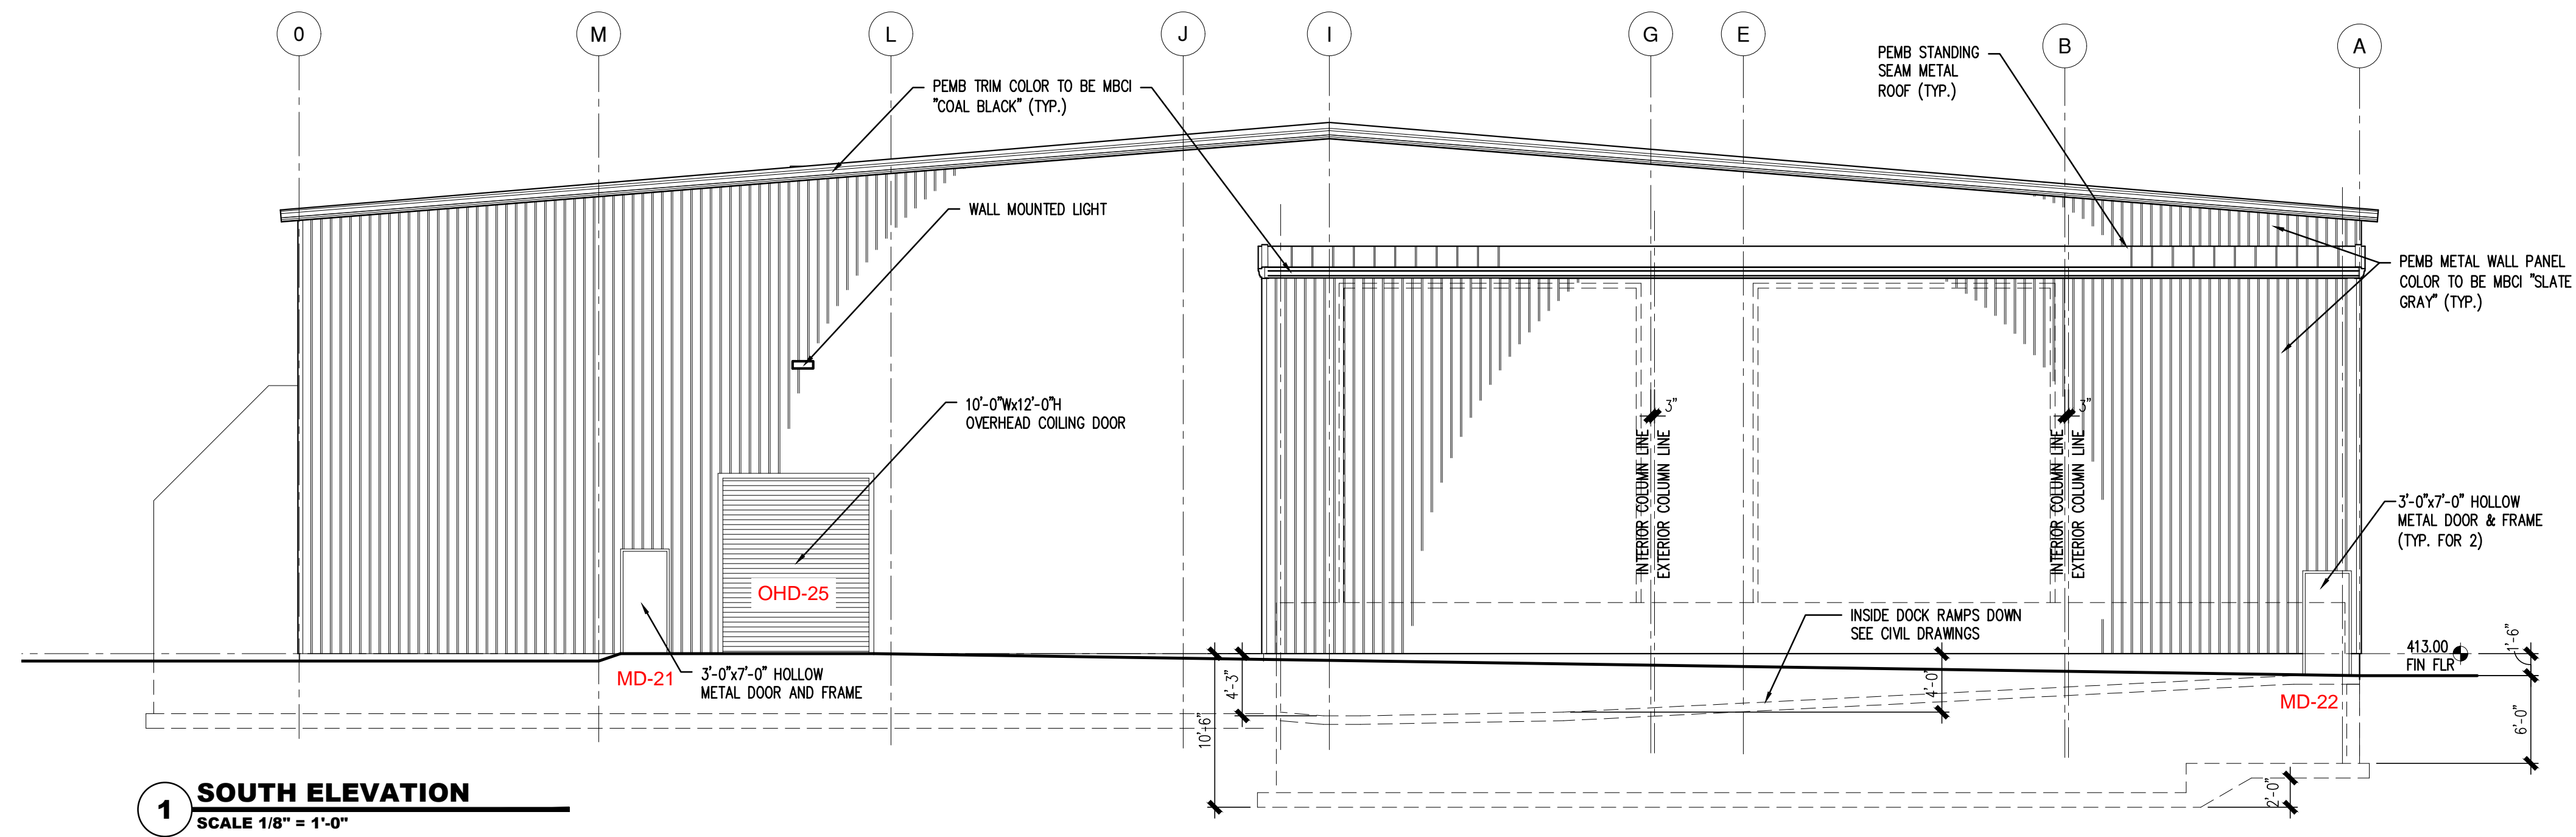

1 SOUTH ELEVATION
SCALE 1/8" = 1'-0"

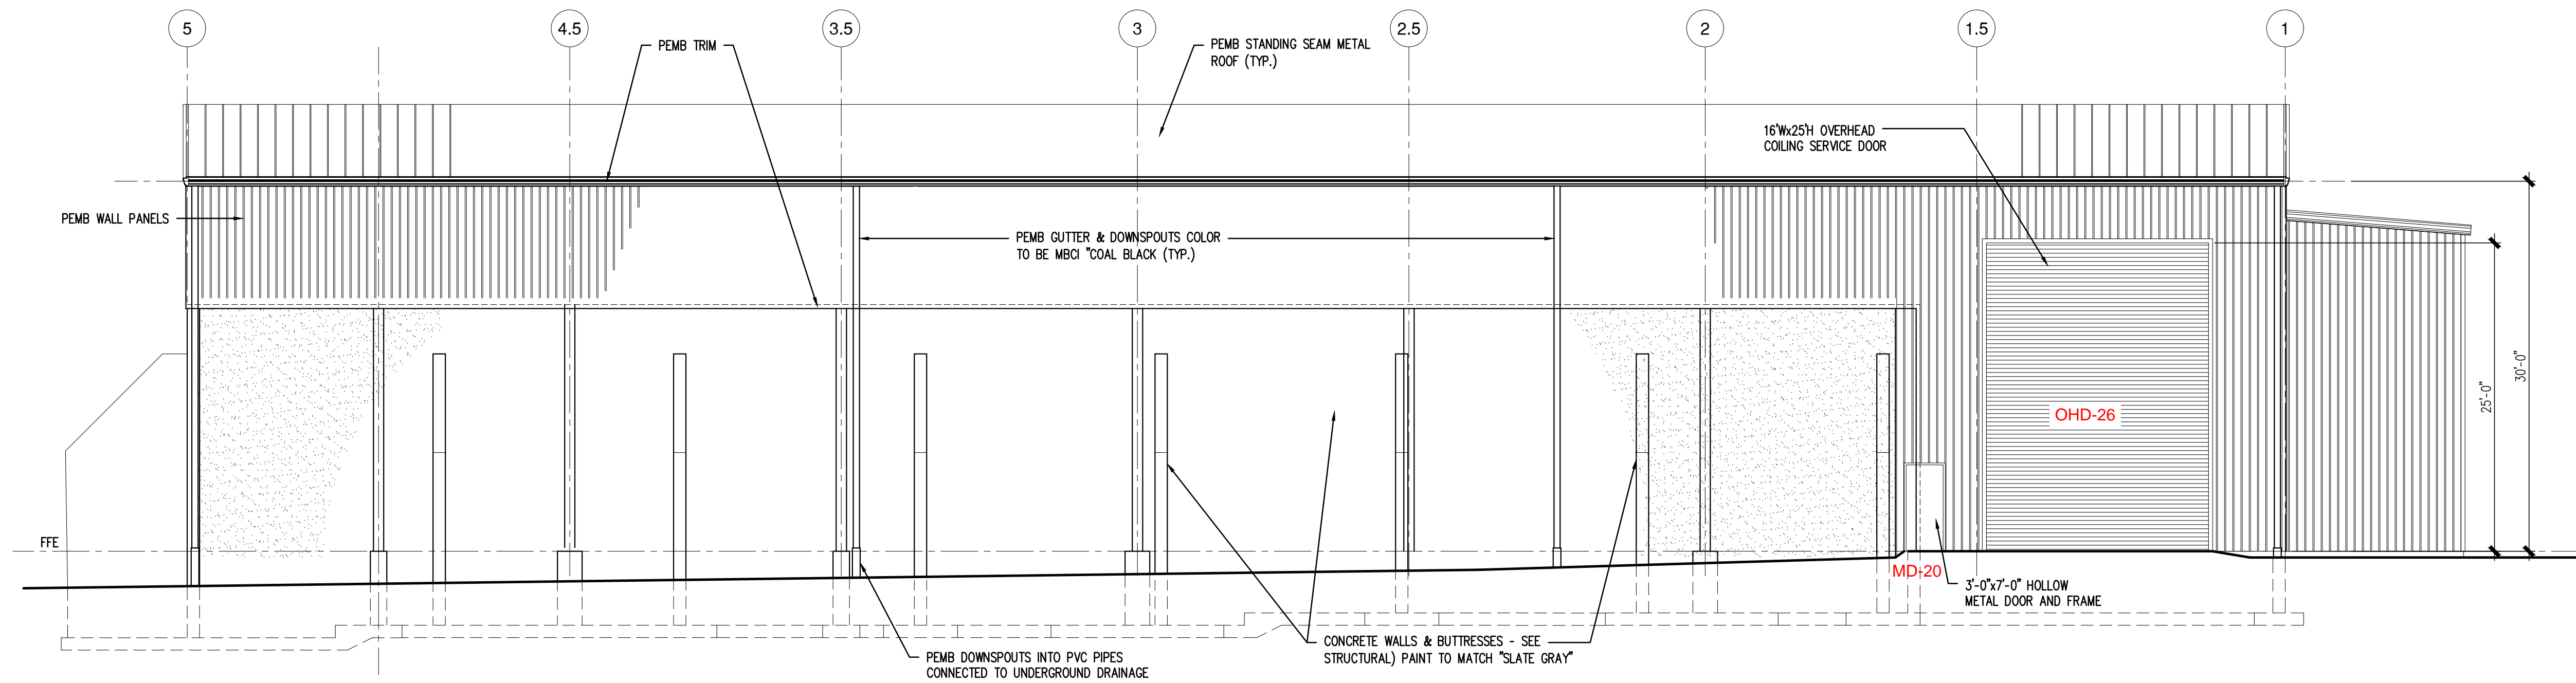

2 EAST ELEVATION
SCALE 1/8" = 1'-0"

EXHIBIT C3

EXHIBIT NAME AND DOOR NUMBERING ADDED BY W-M ENGINEERING

**SYRACUSE HAULERS
FACILITY EXPANSION**

6223 THOMPSON ROAD
SYRACUSE, NEW YORK 13206

COPYRIGHT:
THE ARCHITECT SHALL BE DEEMED
TO HAVE ASSIGNED TO HIMSELF
AND SHALL RETAIN ALL COMMON LAW
STATUTORY AND OTHER RESERVED
RIGHTS, INCLUDING THE COPYRIGHT,
DRAWING ALTERATION
DRAWING ALTERATION
IT IS A VIOLATION OF LAW FOR ANY
PERSON UNLESS ACTING UNDER THE
AUTHORITY OF THE ARCHITECT TO
ALTER ANY ITEM ON THIS DOCUMENT
IN ANY WAY

Schopfer Architects LLP
315-474-6501
FAX 315-474-1922
1111 JAMES ST.
SYRACUSE, NY 13203


Drawn by: MPP
Checked by: FJS
Date: 04-25-2023
Scale: AS NOTED

Revisions:	Number:	Date:	By:
▲			
▲			
▲			

Sheet Title:
**BUILDING
ELEVATIONS**

Sheet No:
A2.2

Job No: 2165

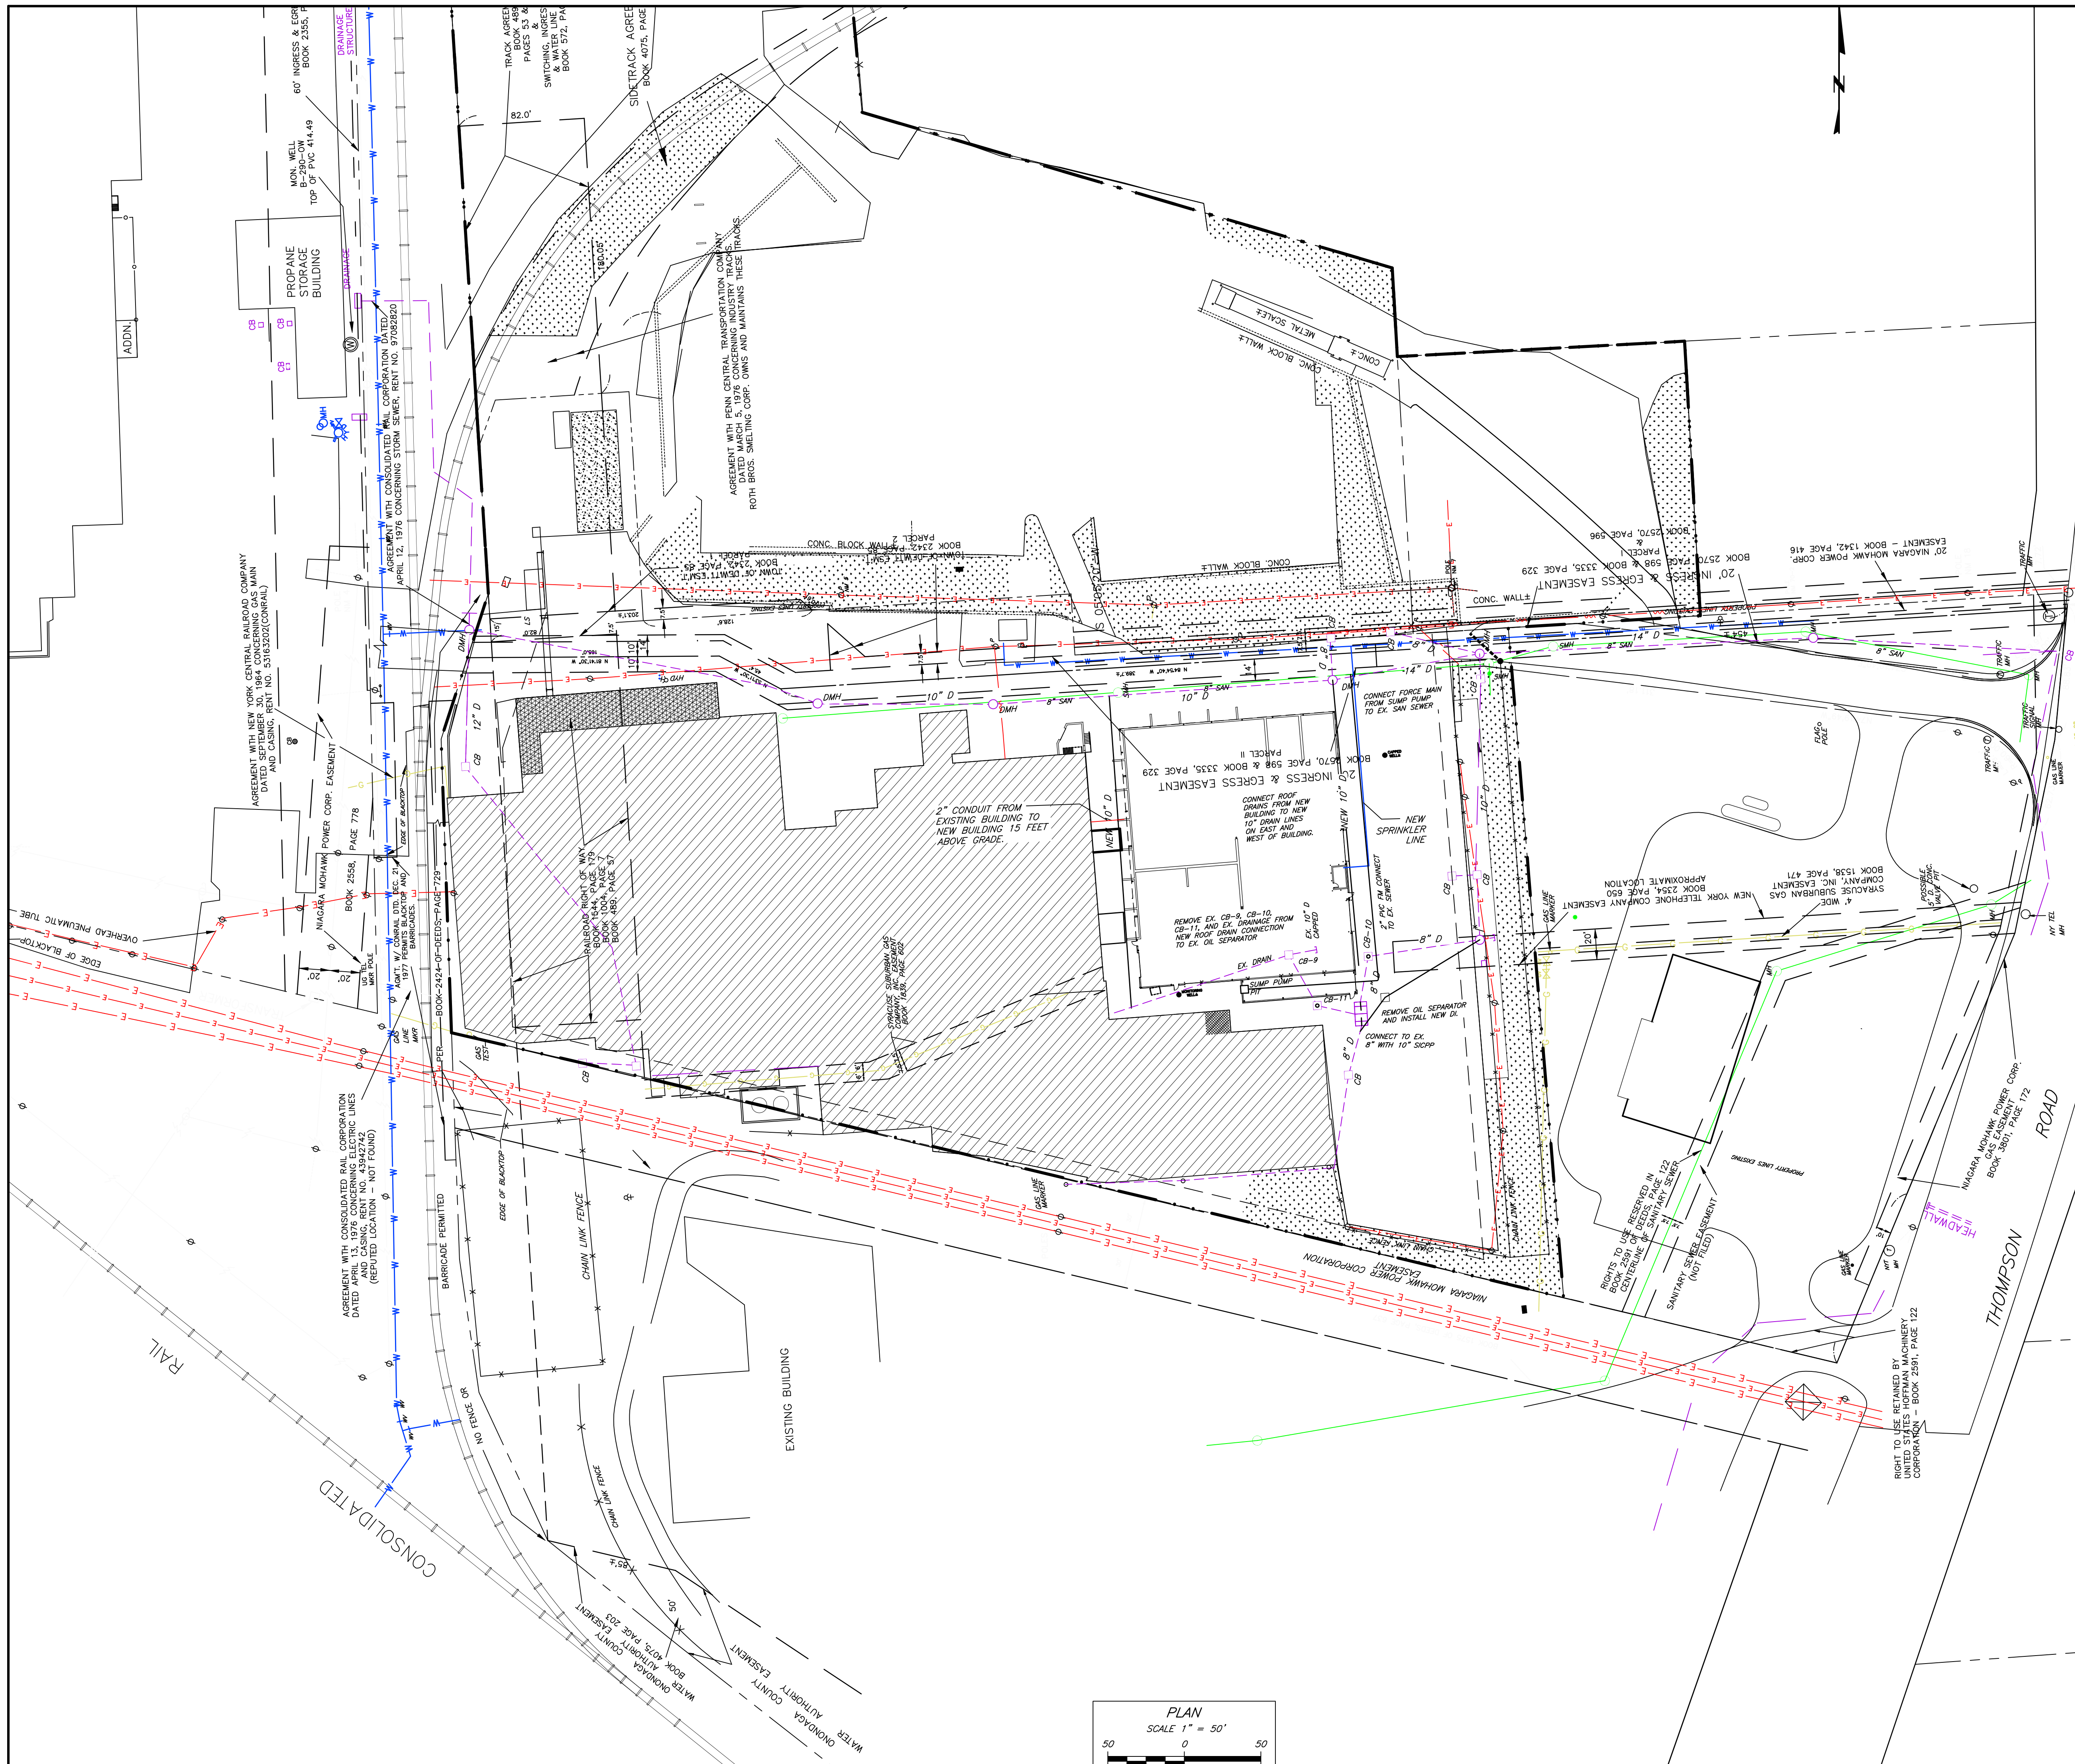


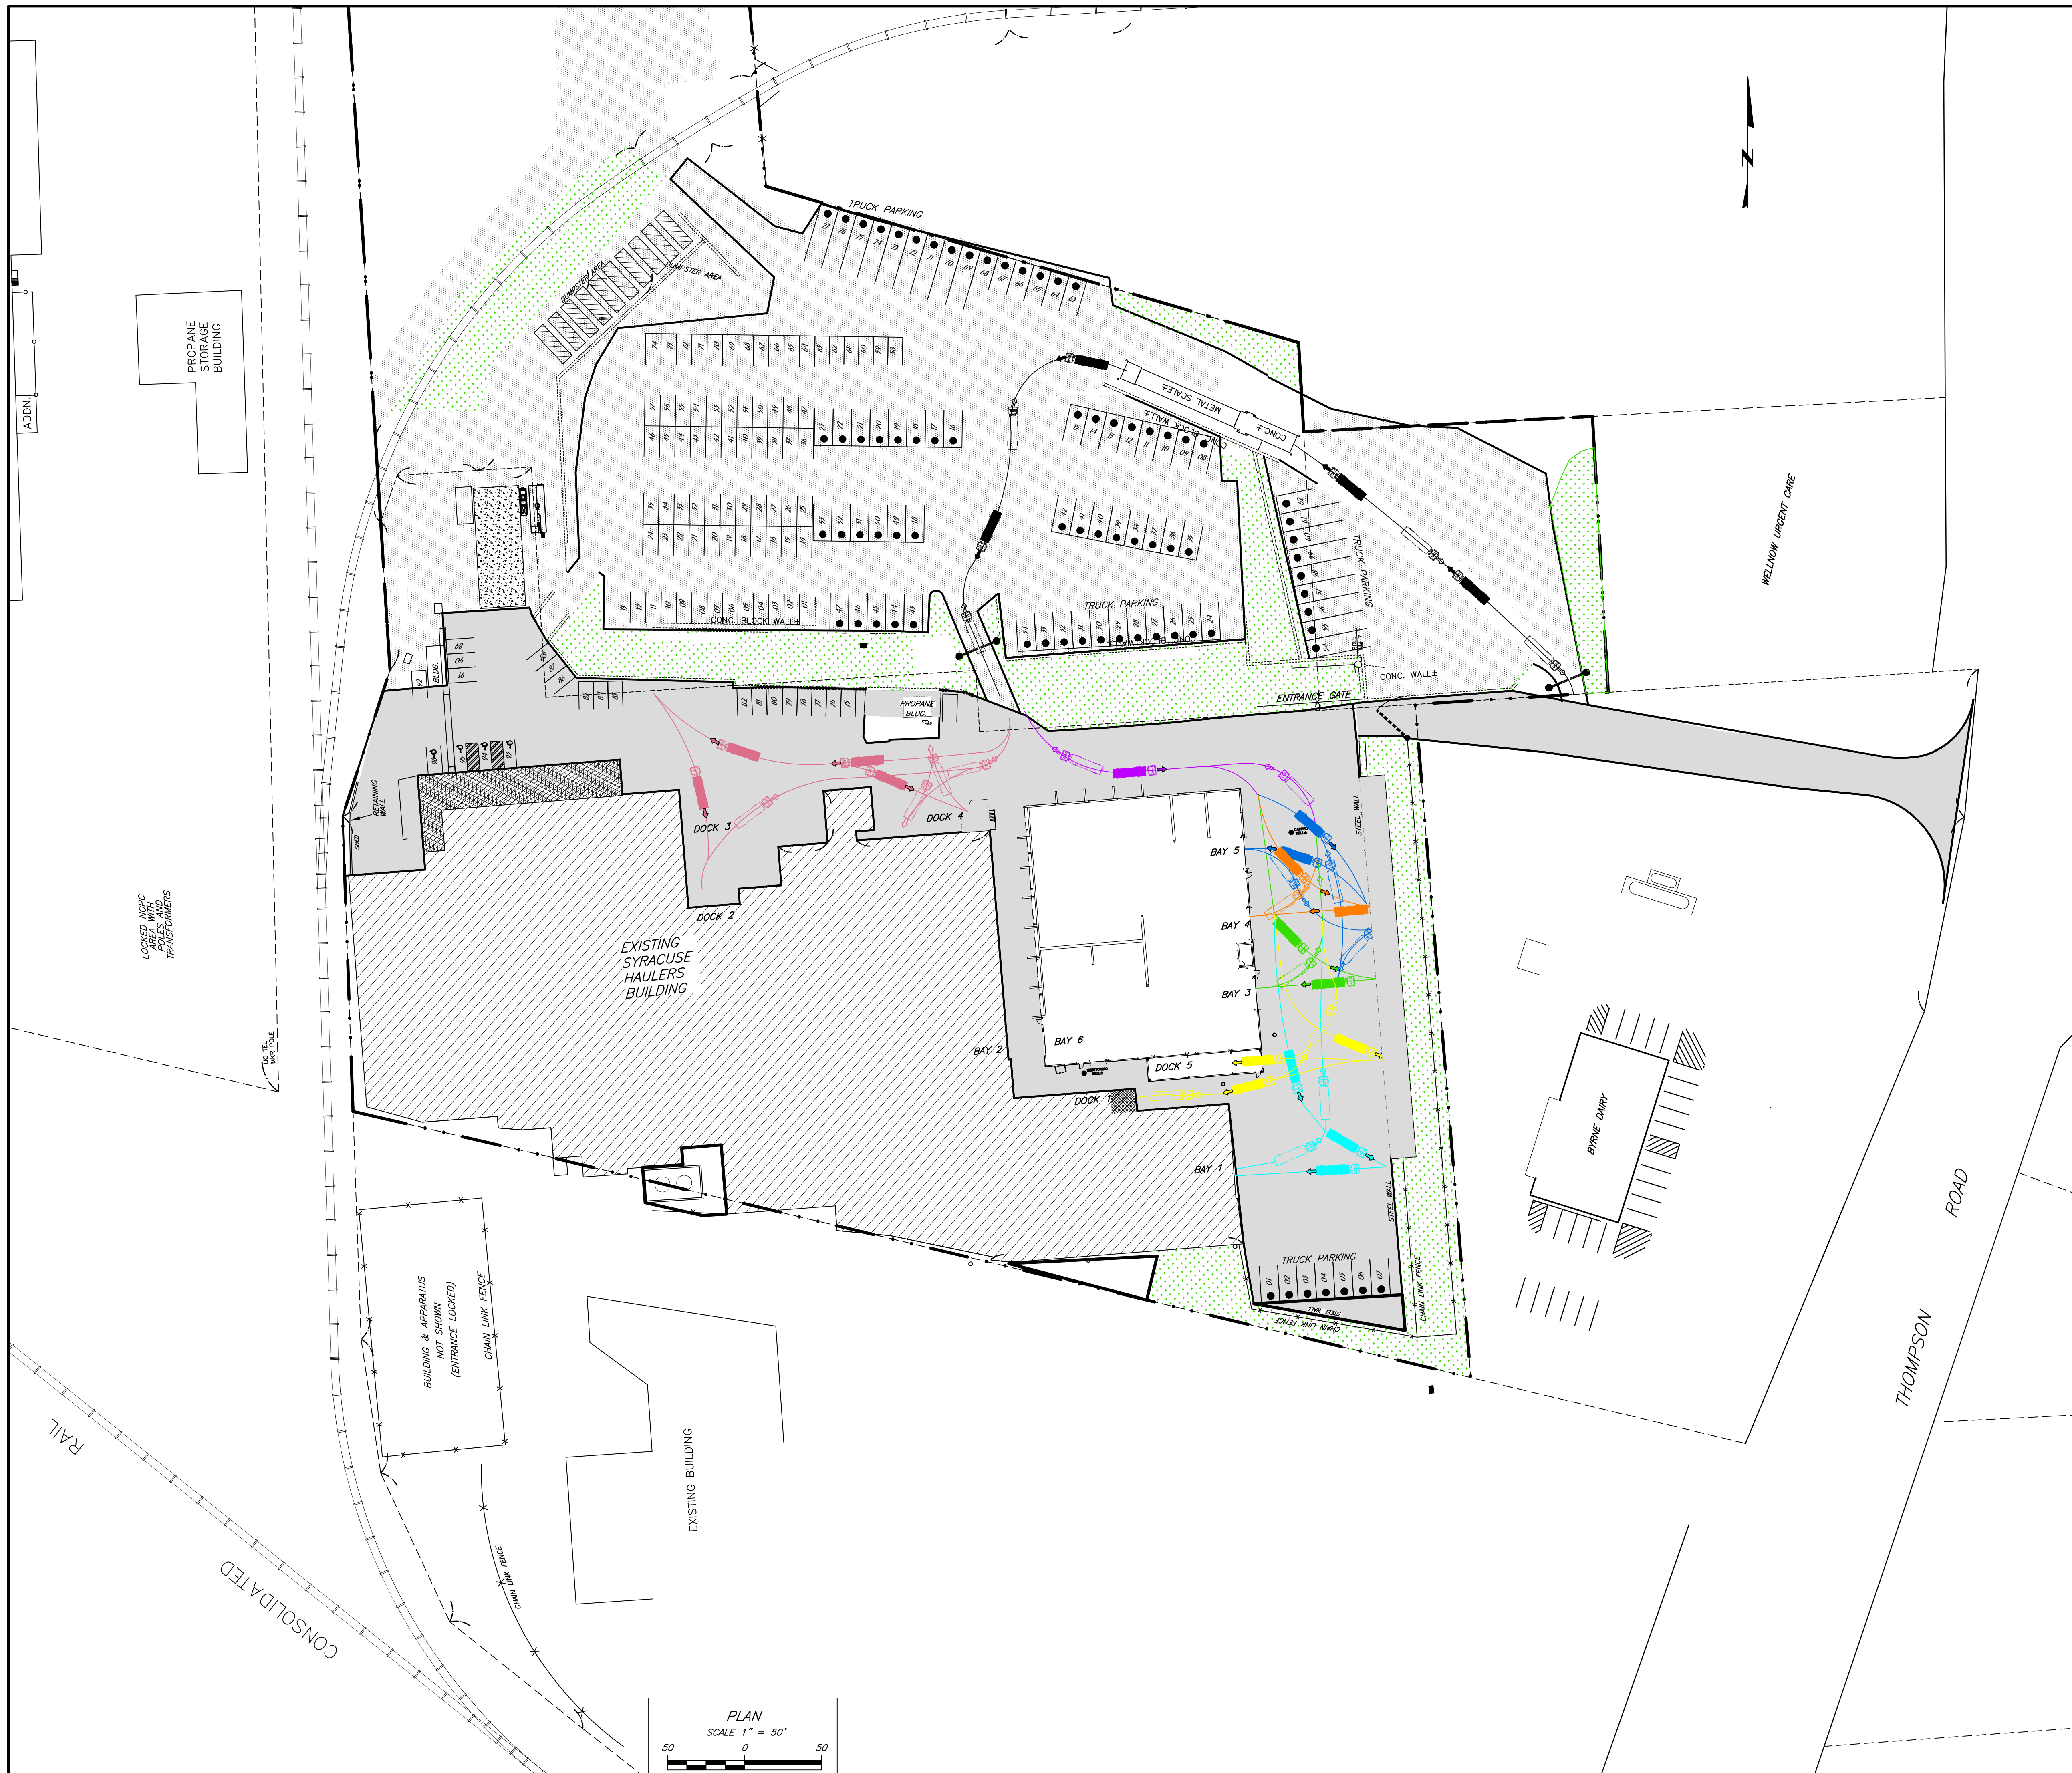
KEY

- FLOW DIRECTION
- CB — EXISTING STORM SEWER
- WS — EXISTING SANITARY SEWER
- G — EXISTING GAS MAIN
- W — EXISTING WATER MAIN
- E — EXISTING ELECTRIC
- R — RAILWAY

NOTE:
ALL UTILITY LOCATIONS ARE APPROXIMATE ACCORDING TO AVAILABLE DATA AND SHOULD BE VERIFIED BEFORE ANY EXCAVATION.

PLAN
SCALE 1" = 50'
50 0 50

WASTEWATER DRAINAGE	W-M ENGINEERING, DPC 101 PIERCEFIELD DR, SOLVAY, NY 13209 315-952-8159 wmore@wmengeers.com	HIGHWAY WATER
		
EXHIBIT D UTILITY LOCATIONS		
SYRACUSE HAULERS FACILITY EXPANSION		
TOWN OF DEWITT	COUNTY OF ONONDAGA	
NO ALTERATION PERMITTED HEREON EXCEPT AS PROVIDED UNDER SECTION 7209 SUBDIVISION 2 OF THE NEW YORK EDUCATION LAW. DATE: AUGUST 26, 2022	SCALE: AS NOTED DRAWN BY: WDM CHECKED BY:	REVISED: 9/13/24 JOB NO. 202104 DWP NO. SHEET NO. OF




NOTES:

1. PARKING DESIGNATED FOR TRUCKS ARE DRAWN AT 12 FT WIDE AND 24 FT IN LENGTH.
2. PARKING DESIGNATED FOR PASSENGER VEHICLES ARE DRAWN AT 10 FT WIDE AND 20 FT IN LENGTH.

SCALE

VTS101 20'x11' PDX STEEL DECK VEHICLE SCALE 200,000 LB CAPACITY
 SIDE RAILS
 IND780 PDX DRIVE SCALE TERMINAL
 ADI 310 REMOTE DISPLAY WITH 2 R/G TRAFFIC LIGHTS
 APR 310 TICKET PRINTER WITH CABLE
 SCALE FOUNDATION
 CONCRETE RAMPS
 RADCOMM RADIATION DETECTION

- KEY**
- INCOMING TRUCK TRAFFIC
 - OUTGOING TRUCK TRAFFIC
 - INCOMING TRUCK TRAFFIC - PHASE 1
 - OUTGOING TRUCK TRAFFIC - PHASE 1
 - INCOMING TRUCK TRAFFIC - BAY 1
 - OUTGOING TRUCK TRAFFIC - BAY 1
 - INCOMING TRUCK TRAFFIC - DOCK 1 & 7
 - OUTGOING TRUCK TRAFFIC - DOCK 1 & 7
 - INCOMING TRUCK TRAFFIC - BAY 4
 - OUTGOING TRUCK TRAFFIC - BAY 4
 - INCOMING TRUCK TRAFFIC - BAY 5
 - OUTGOING TRUCK TRAFFIC - BAY 5
 - INCOMING TRUCK TRAFFIC - BAY 6
 - OUTGOING TRUCK TRAFFIC - BAY 6
 - INCOMING TRUCK TRAFFIC - DOCK 2
 - OUTGOING TRUCK TRAFFIC - DOCK 2
 - ROLL-OFF DUMPSTERS
 - TRUCK PARKING SPACES (77)
 - PASSENGER CAR PARKING SPACES (96)
 - ENTRANCE GATE
 - OFFICE
 - ASPHALT PAVEMENT
 - GRAVEL PAVEMENT
 - VEGETATION

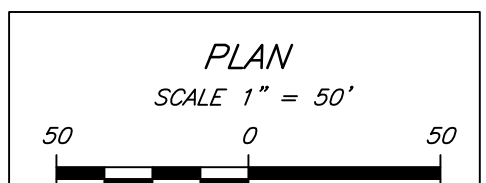

WASTEWATER DRAINAGE	W-M ENGINEERING, DPC 101 PIERCEFIELD DR, SOLVAY, NY 13209 315-952-8159 wmore@wmengeers.com	HIGHWAY WATER
EXHIBIT E TRAFFIC AND PARKING PLAN NEW BUILDING		
SYRACUSE HAULERS FACILITY EXPANSION		
TOWN OF DEWITT	COUNTY OF ONONDAGA	
NO ALTERATION PERMITTED HEREON EXCEPT AS PROVIDED UNDER SECTION 7209 SUBDIVISION 2 OF THE NEW YORK EDUCATION LAW.	SCALE: AS NOTED DRAWN BY: WDM	REVISOR: JOB NO. 202104 DWG NO. 202104-1TP SHEET NO. OF
DATE: SEPTEMBER 13, 2024	CHECKED BY:	

